


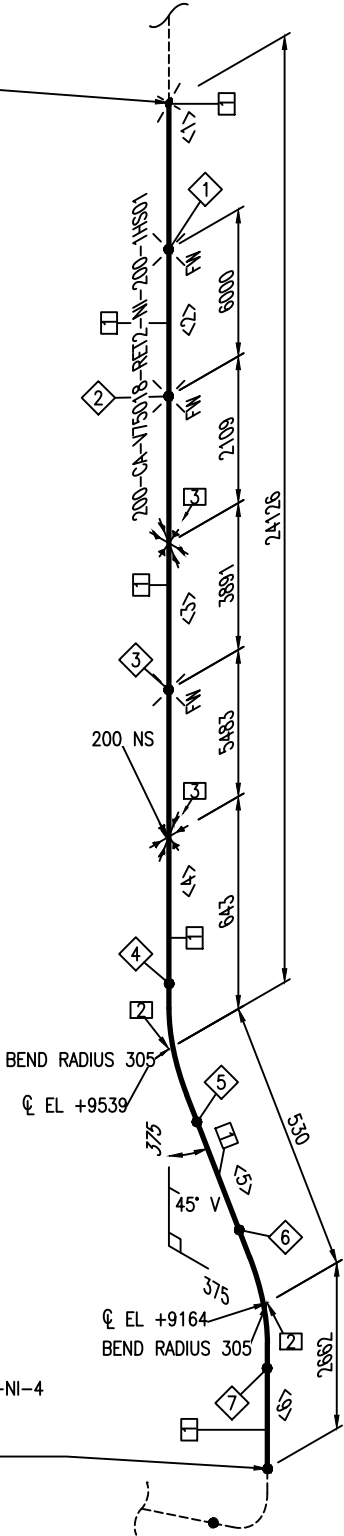

CONT'D FROM
DWG#
200-CA-V75018-RET2-NI-2
W 6013
N 15896
EL +33665



CONT'D ON
DWG#
200-CA-V75018-RET2-NI-4
W 6013
N 15521
EL +6502

1	ZAPRACOVÁNÍ PŘÍPOMÍNEK	26.03.2024	KO	ŽV	UJ
0	BASIC DESIGN		KO	ŽV	UJ
REV.	DESCRIPTION	DATE	DRAWN	CHKD	APPD

SERVICE	
PIPE SPEC	
MAX PRESSURE	
MAX TEMPERATURE	
P&ID DWG	
INSULATION SPEC	
INSULATION THK	

BILL OF MATERIALS				
ID	QTY	ND	SCH/CLASS	DESCRIPTION
PIPE				
1	26.9M	200		PIPE HOT ROLLED 219,1X3
FITTINGS				
2	2	200		BEND 90-3-219,1-3
PIPE SUPPORTS				
3	2	200		PIPE HANGER

PROJECT NAME:				Úprava výduchu cyklónu 2-S-7510			
TITLE:							
DRAWING NUMBER:				MM-23019-BD-008.3			
LINE NO:		200-CA-V75018-RET2-NI		AREA:	UNIT:	TYPE:	
JOB NUMBER:				SCALE:	SHEET:		REV.
				N.T.S.	3 of 4		1